


100mm DUCT TO CONTROL ROOM  
AND POWER SUPPLY


SERVICE  
MANHOLE

EIGHT M24 H.D. BOLTS  
(BY OTHERS)

FOUR M12 H.D. BOLTS  
(BY OTHERS)

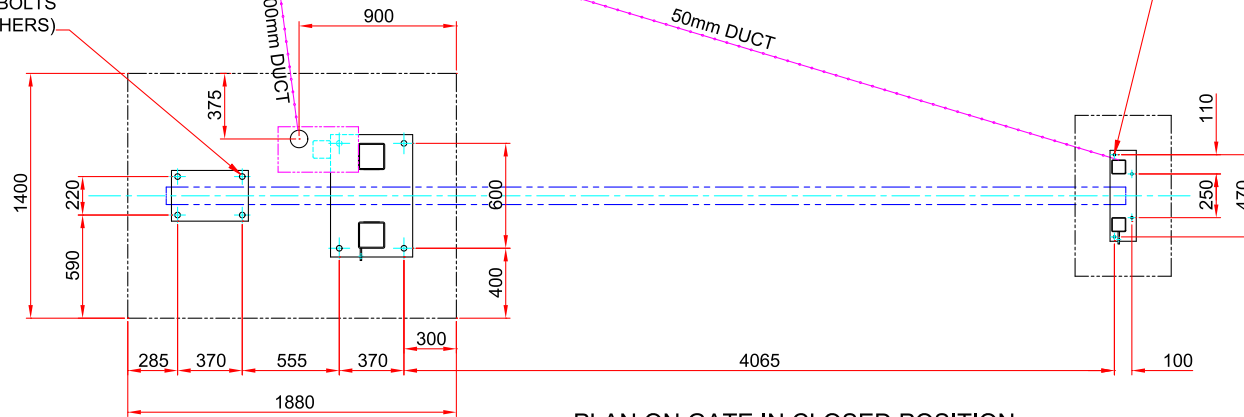

PLAN ON GATE IN CLOSED POSITION

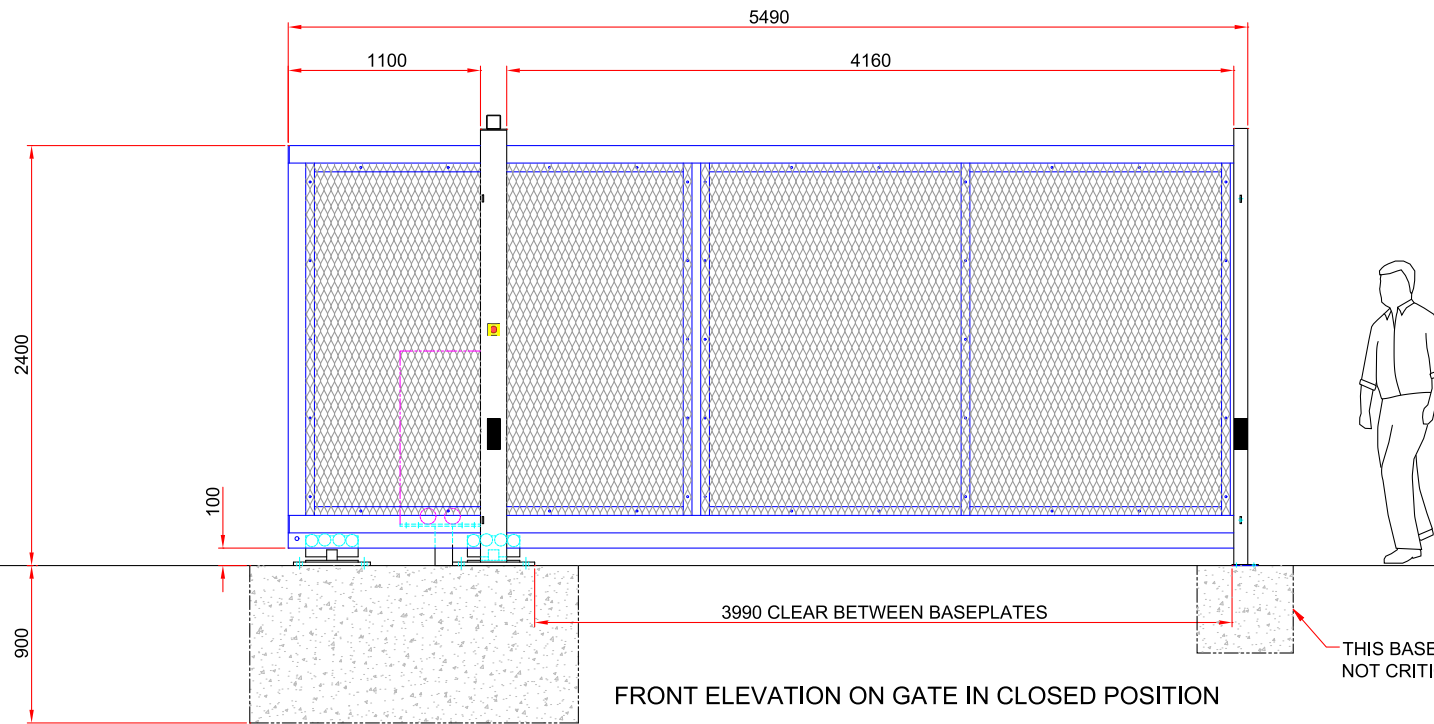

FRONT ELEVATION ON GATE IN CLOSED POSITION

**PARAMOUNT**  
Steelfence

**SAFESLIDE**

4m wide fully automatic gate, closes to right  
Standard base detail & ducting arrangement

DRG No

**SS/4/A/R**